


**BUILDING 'A' ELECTRICAL PLAN**

SCALE: 3/16"=1'-0"

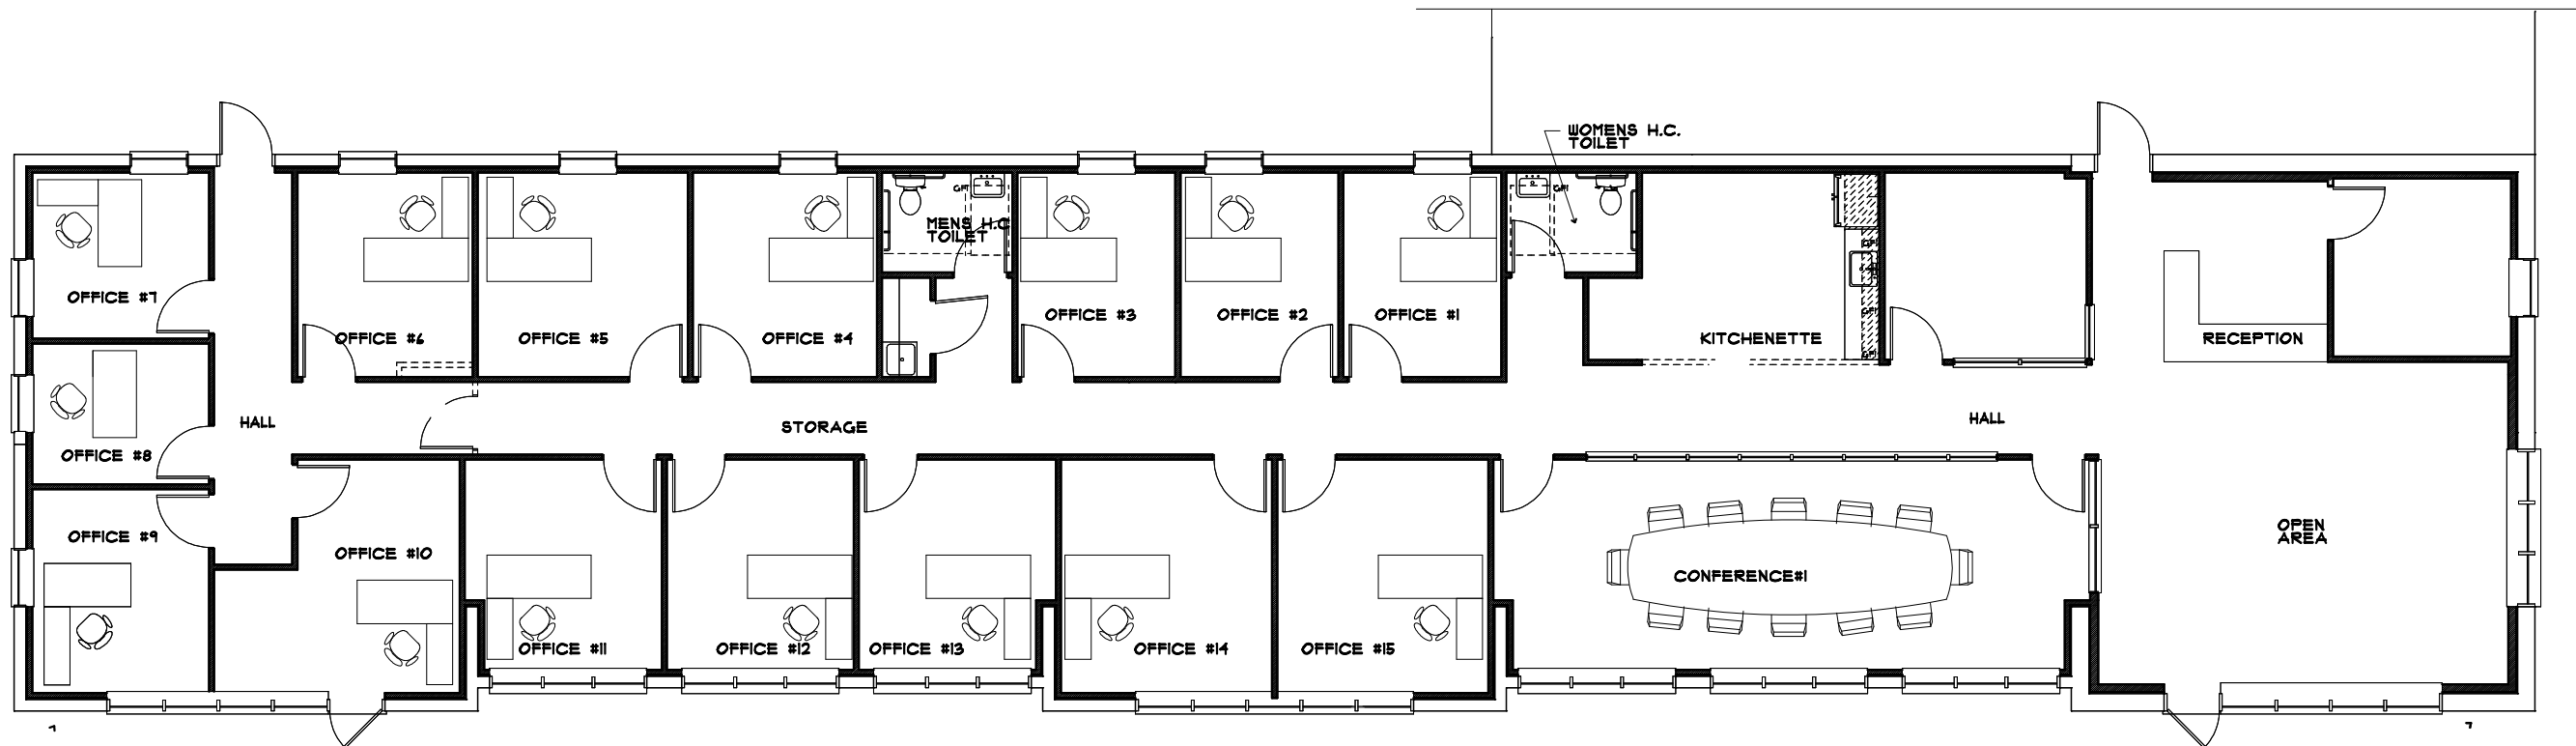

**BUILDING 'B' ELECTRICAL PLAN**

SCALE: 3/16"=1'-0"